



BUILDING MANAGEMENT UNIT
EULEX-KOSOVO




PROJECT TITLE:
New WH Compound

LOCATION: PRISHTINA

DRAWING TITLE:
ELECTRICAL - SITUATION

APPROVED BY:	
CHECKED BY:	
DESIGNED BY:	EULEX-BMU
SCALE:	1:50
UNITS:	cm
DRAWING NO:	E-01
DATE:	January 2013

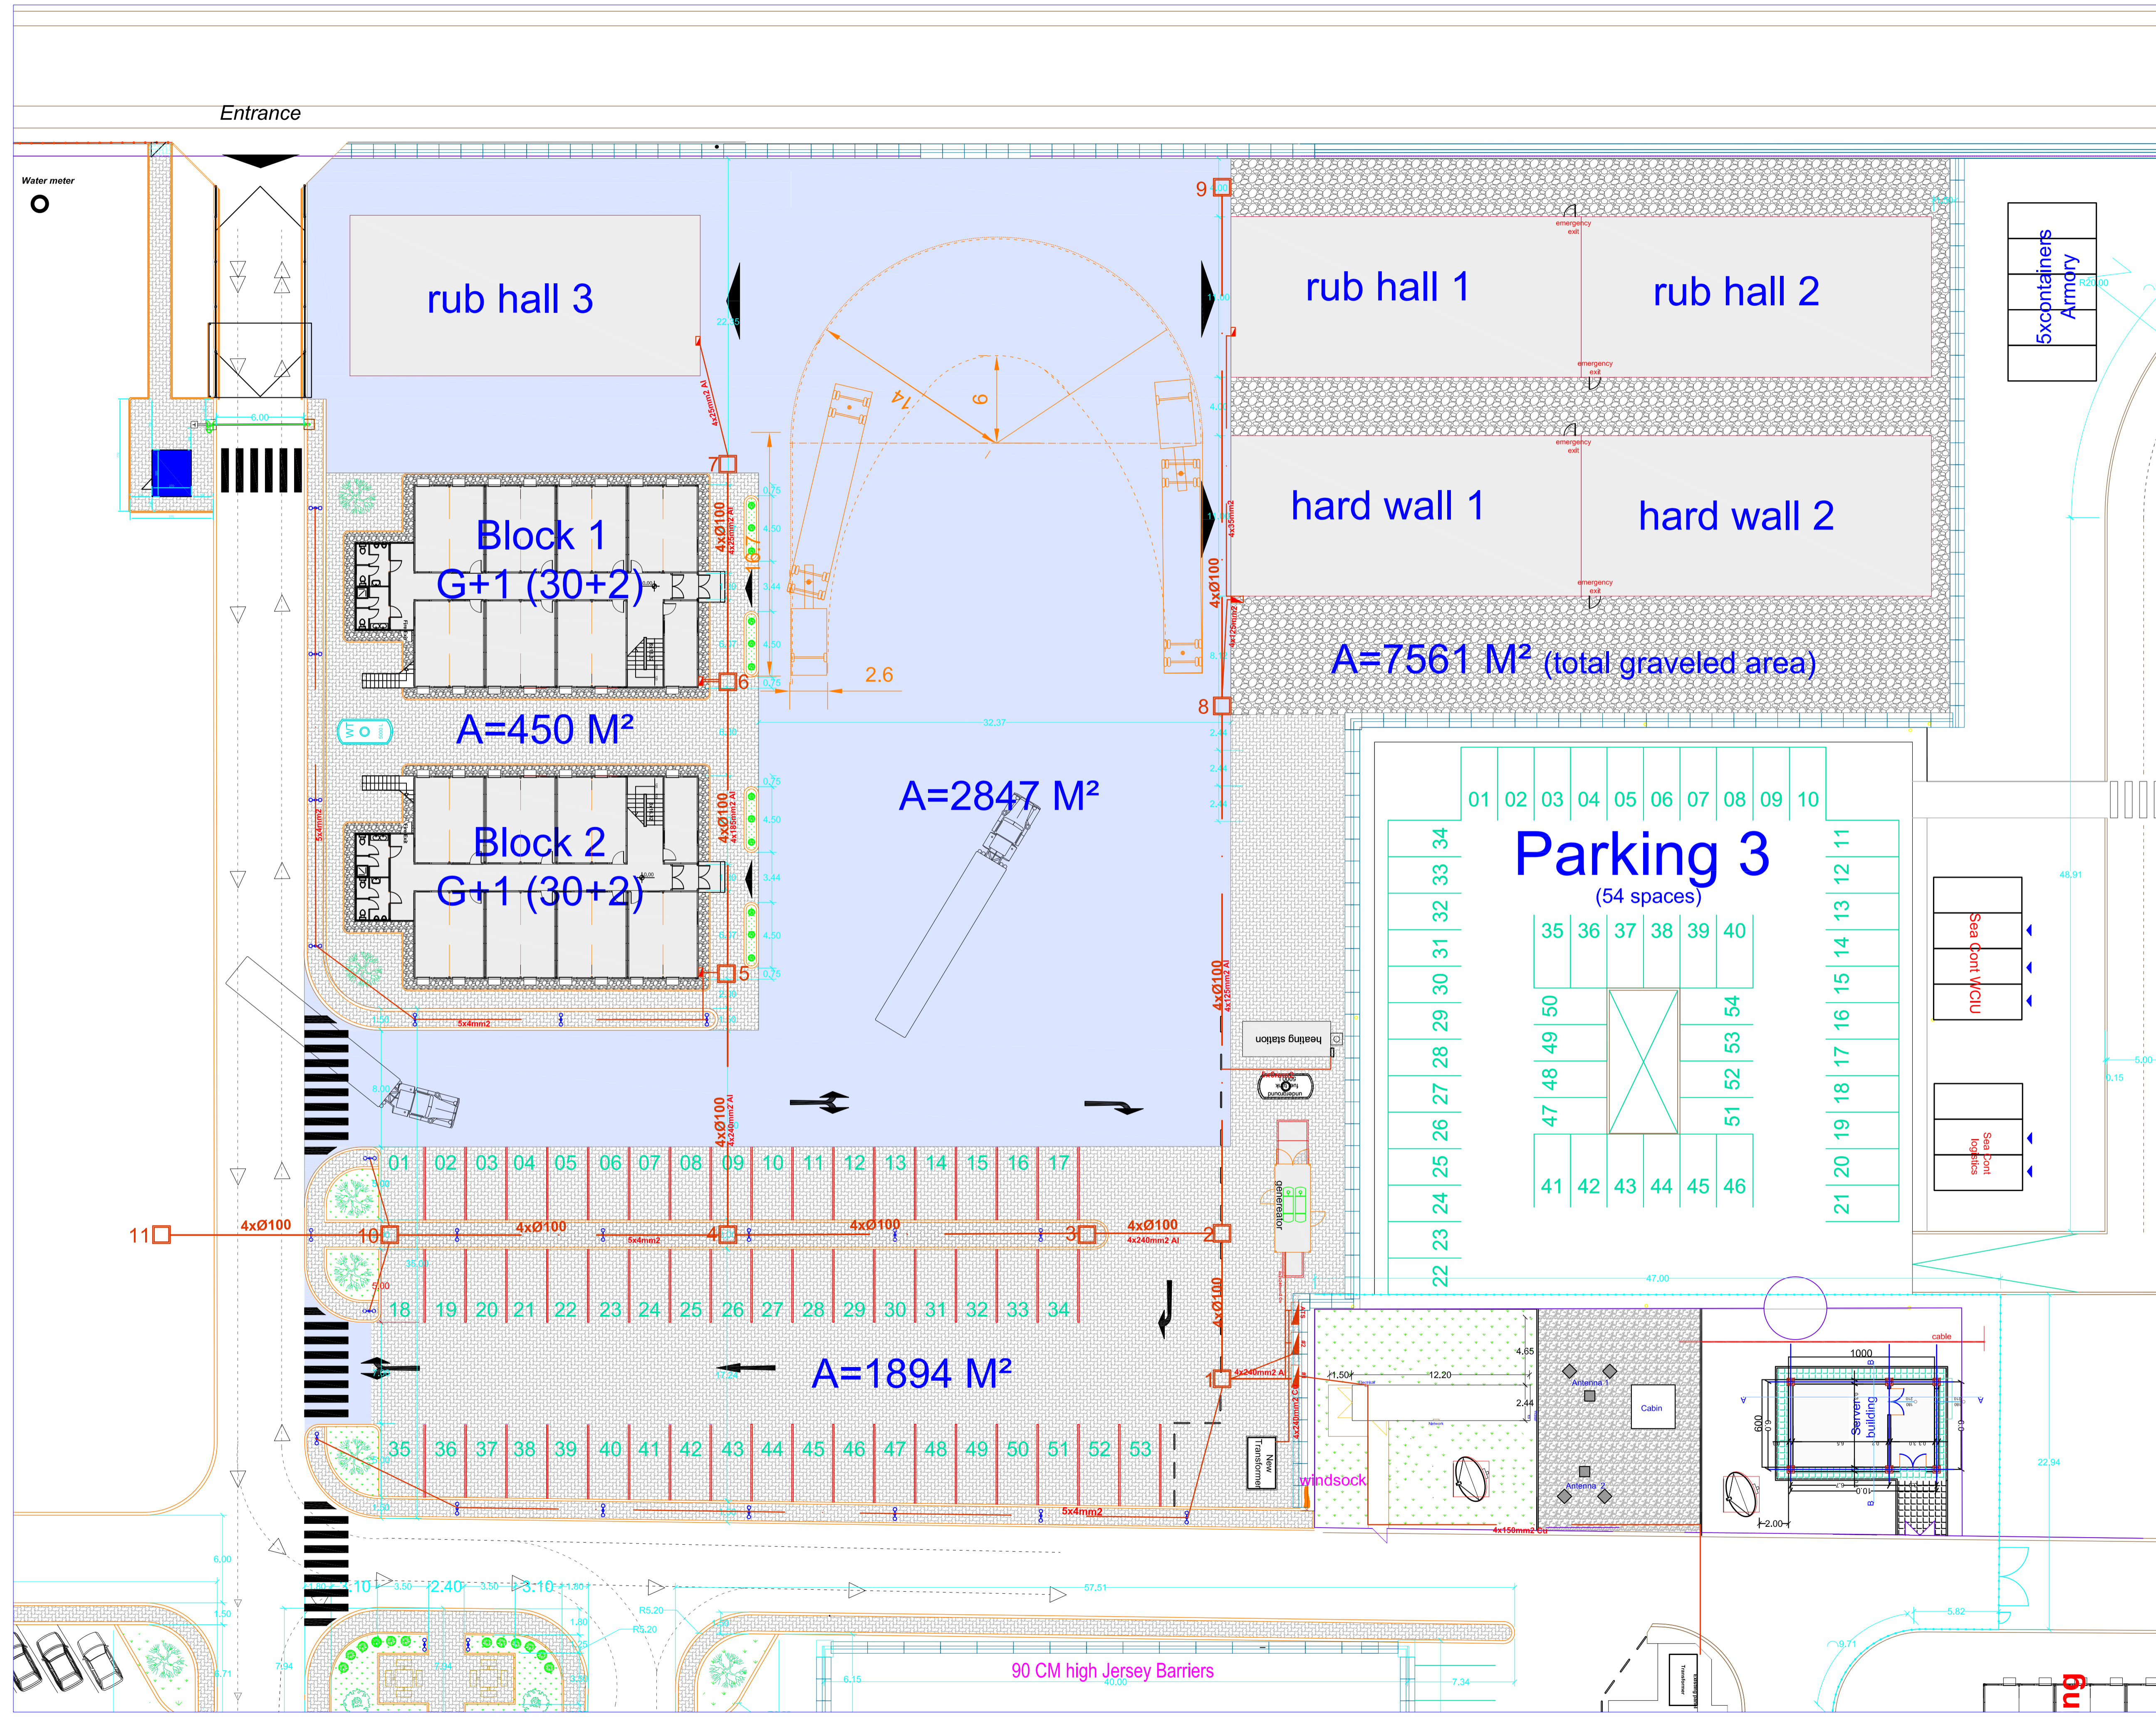

Entrance

Water meter

rub hall 3

rub hall 1

rub hall 2

5x containers
Armory

Block 1
G+1 (30+2)

hard wall 1

hard wall 2

A=450 M²

A=7561 M² (total paved area)

Block 2
G+1 (30+2)

A=2847 M²

Parking 3
(54 spaces)

A=1894 M²

90 CM high Jersey Barriers

Sea Port
WCU

Sea Port
Logistics

Cabin

Server
building

windssock




 







ing



BUILDING MANAGEMENT UNIT
EULEX-KOSOVO



LEGEND





-  Distribution Box
-  Fluorescent light unit 4x18W
-  Fluorescent Light Unit 2x36
-  Fluorescent Light Unit 1x36
-  Fluorescent Light Unit 1x18
-  Emergency Light unit
-  Light switches
-  1p/220V-Socket outlet
-  1p/220V- Socket outlet double
-  External Street light 125W
-  3p/380V : Socket outlet
Priza :3p/380V

PROJECT TITLE:
New WH Compound

LOCATION: PRISHTINA


DRAWING TITLE:
CONTAINER BLOCK 1&2
ELECTRICAL FLOOR PLAN

APPROVED BY:	
CHECKED BY:	
DESIGNED BY:	EULEX-BMU
SCALE:	1:100
UNITS:	cm
DRAWING NO:	E-02
DATE:	January 2013
	FORMAT A1

 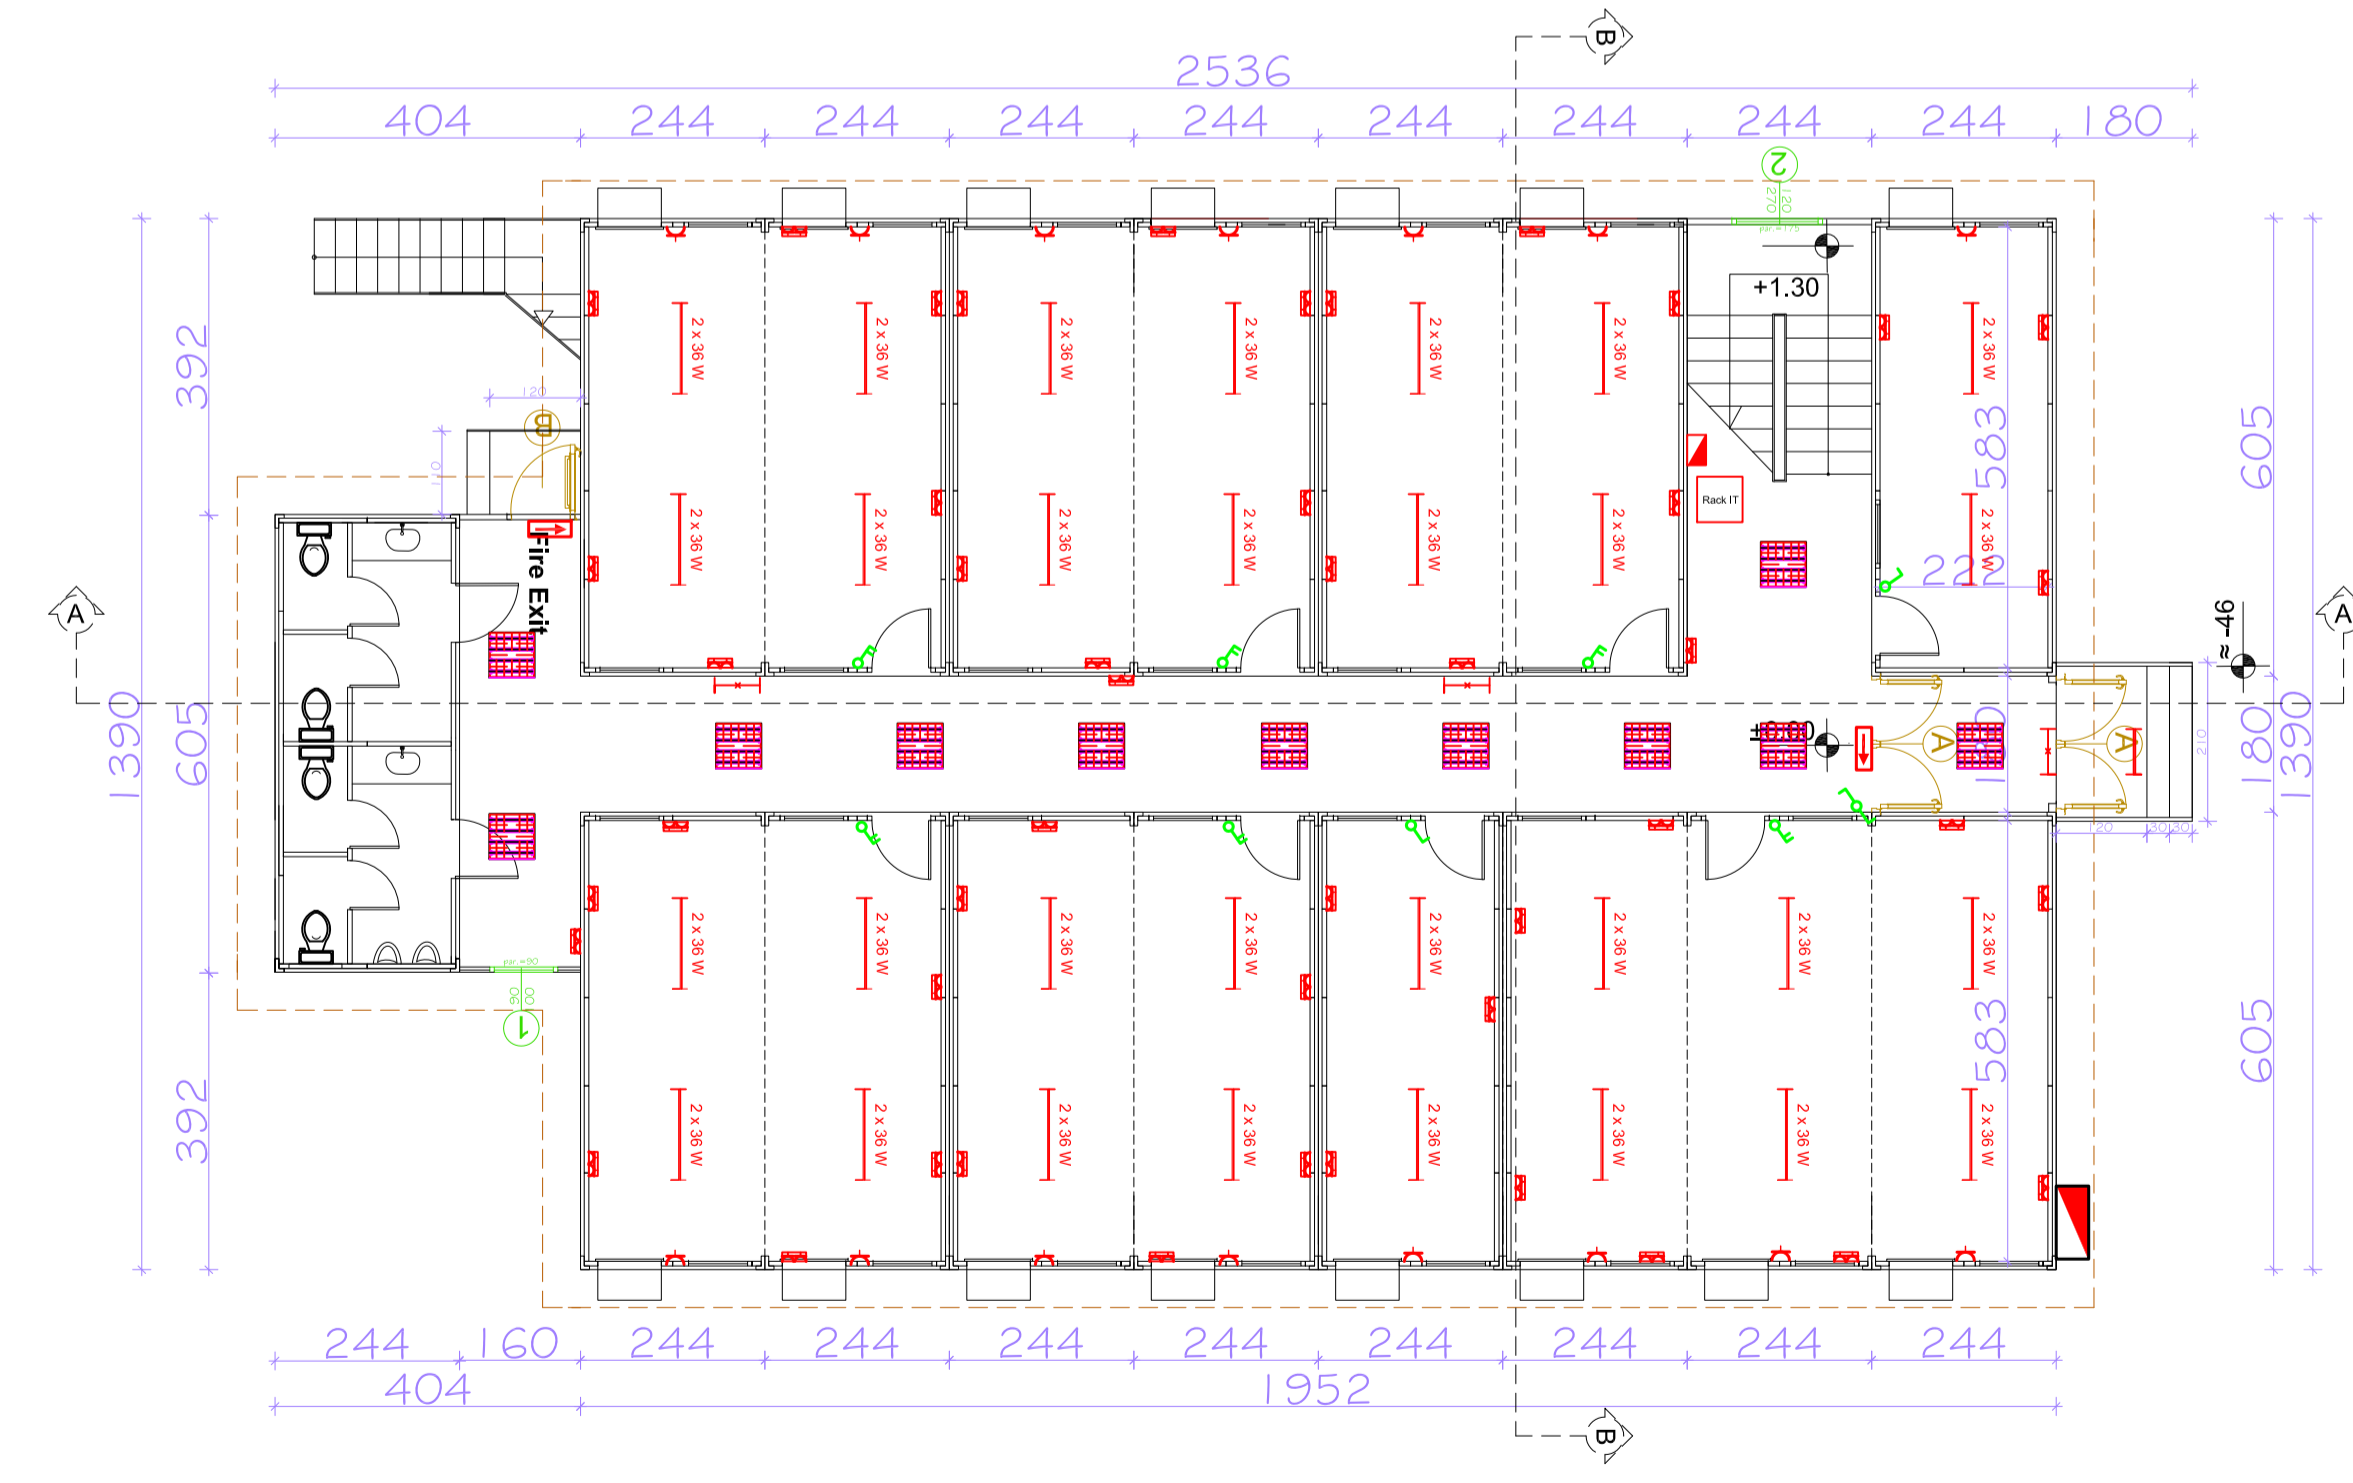
 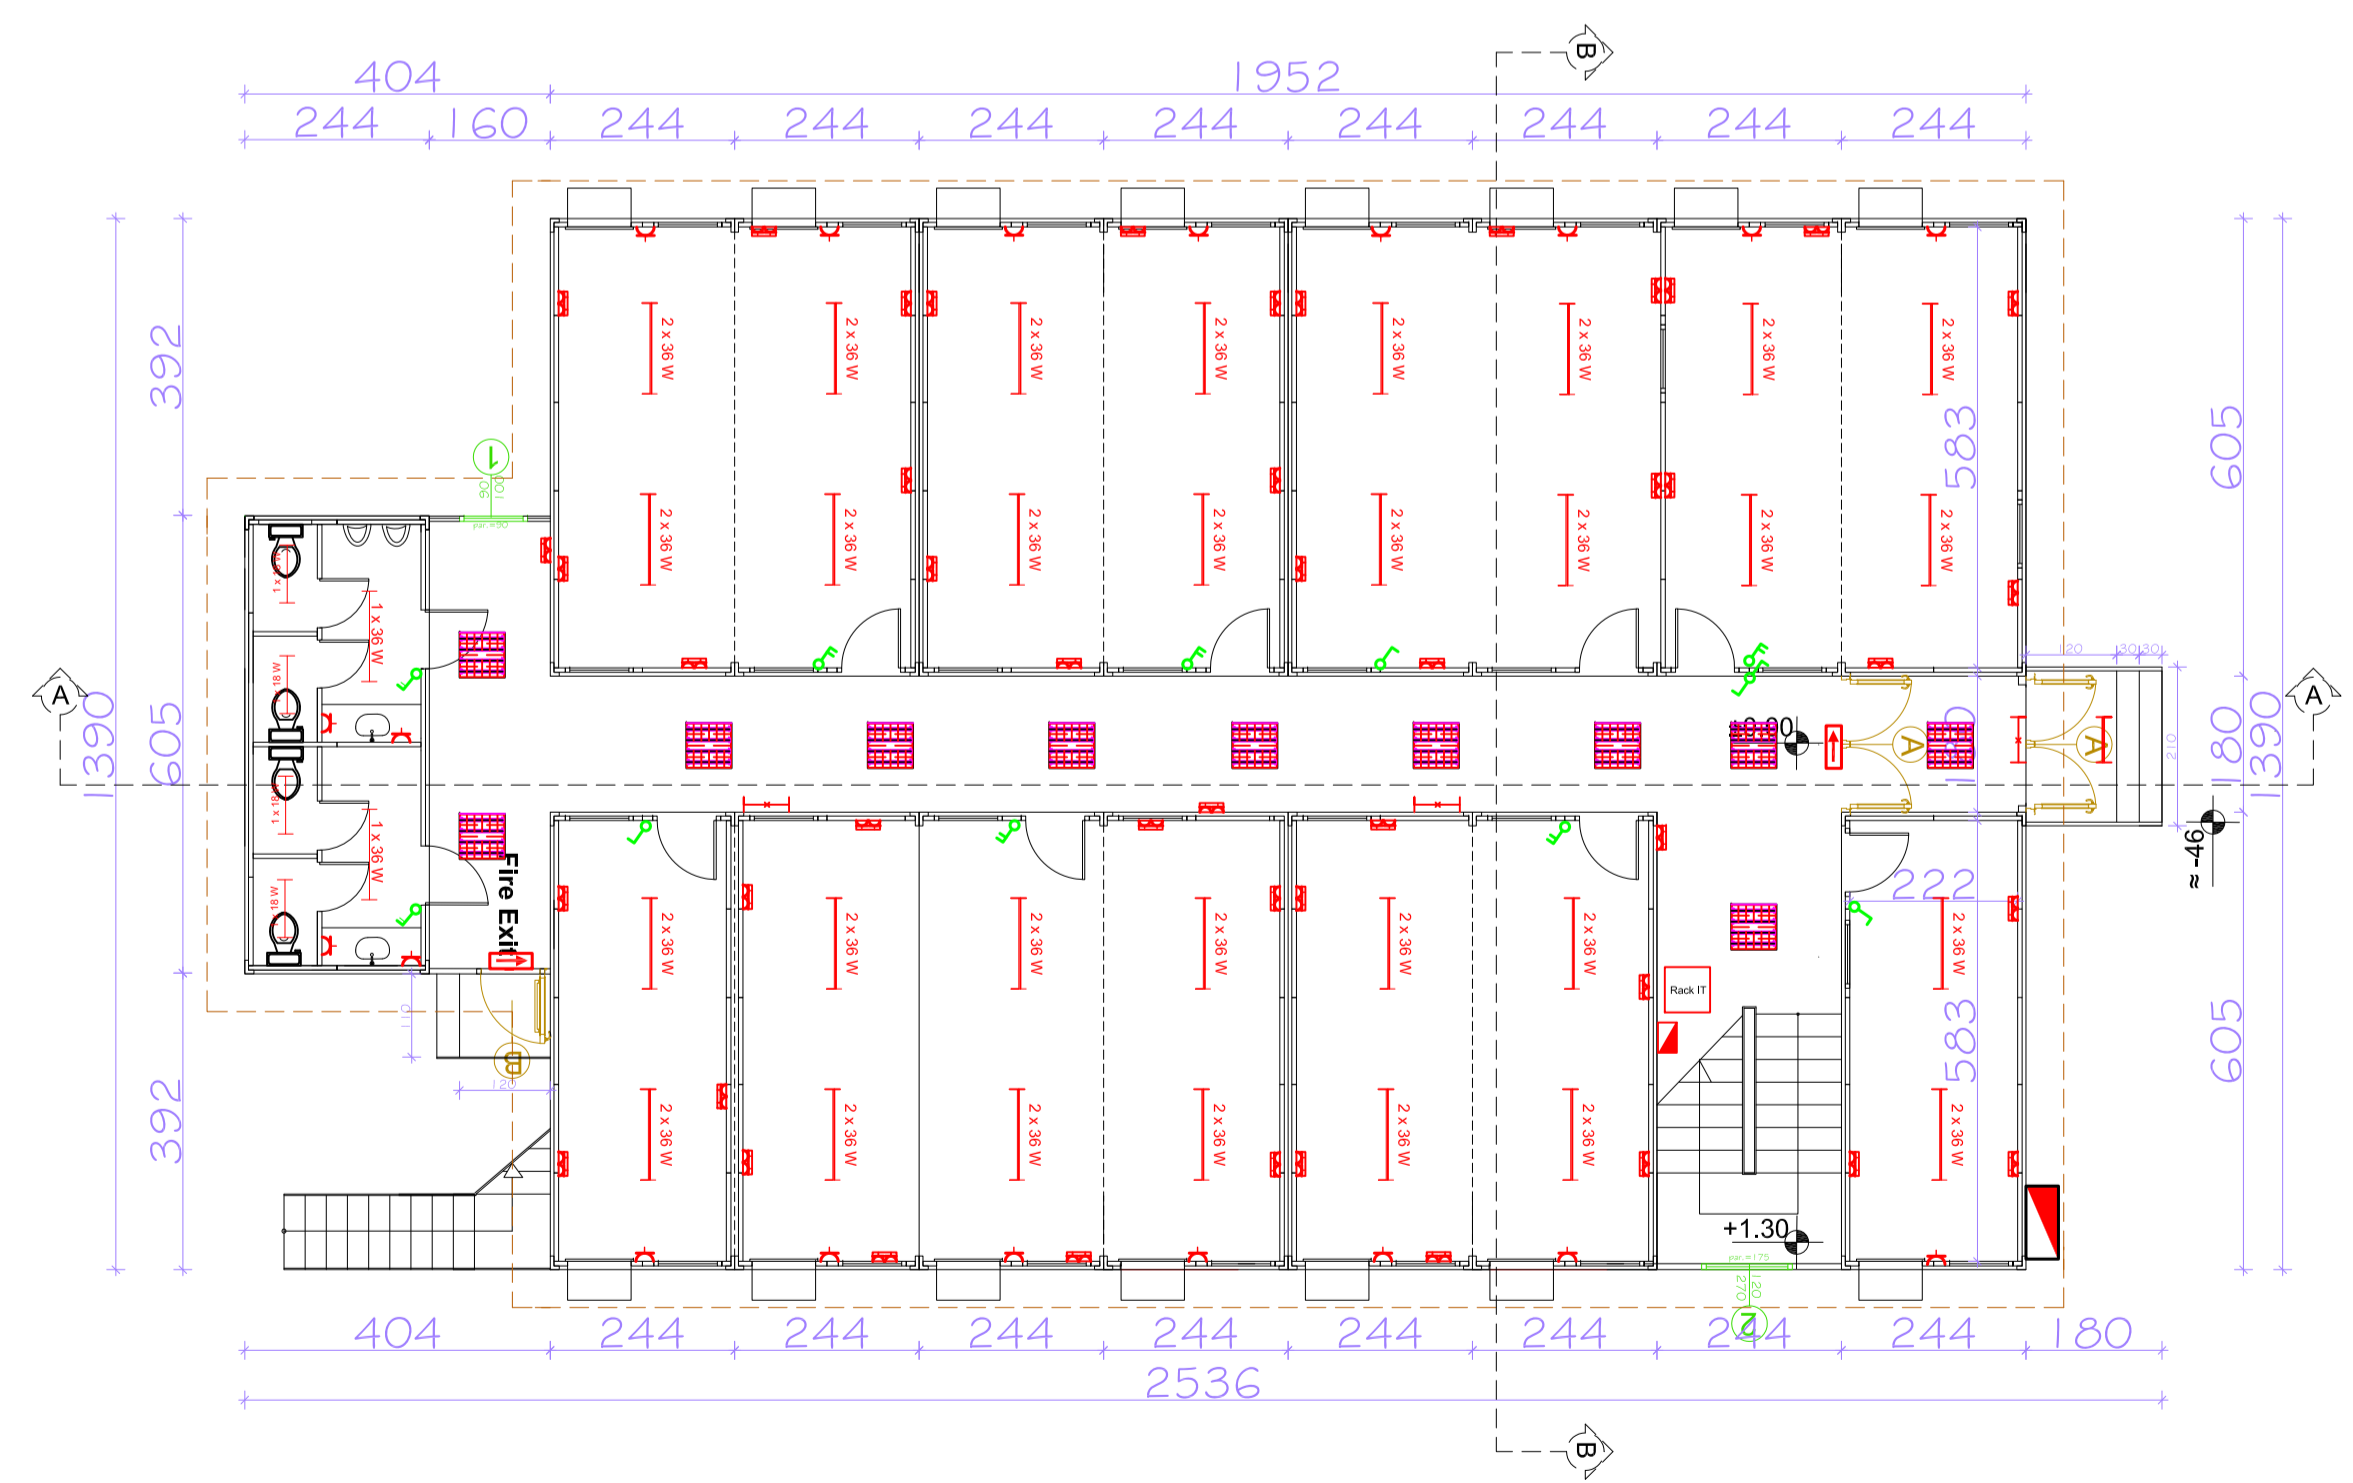
 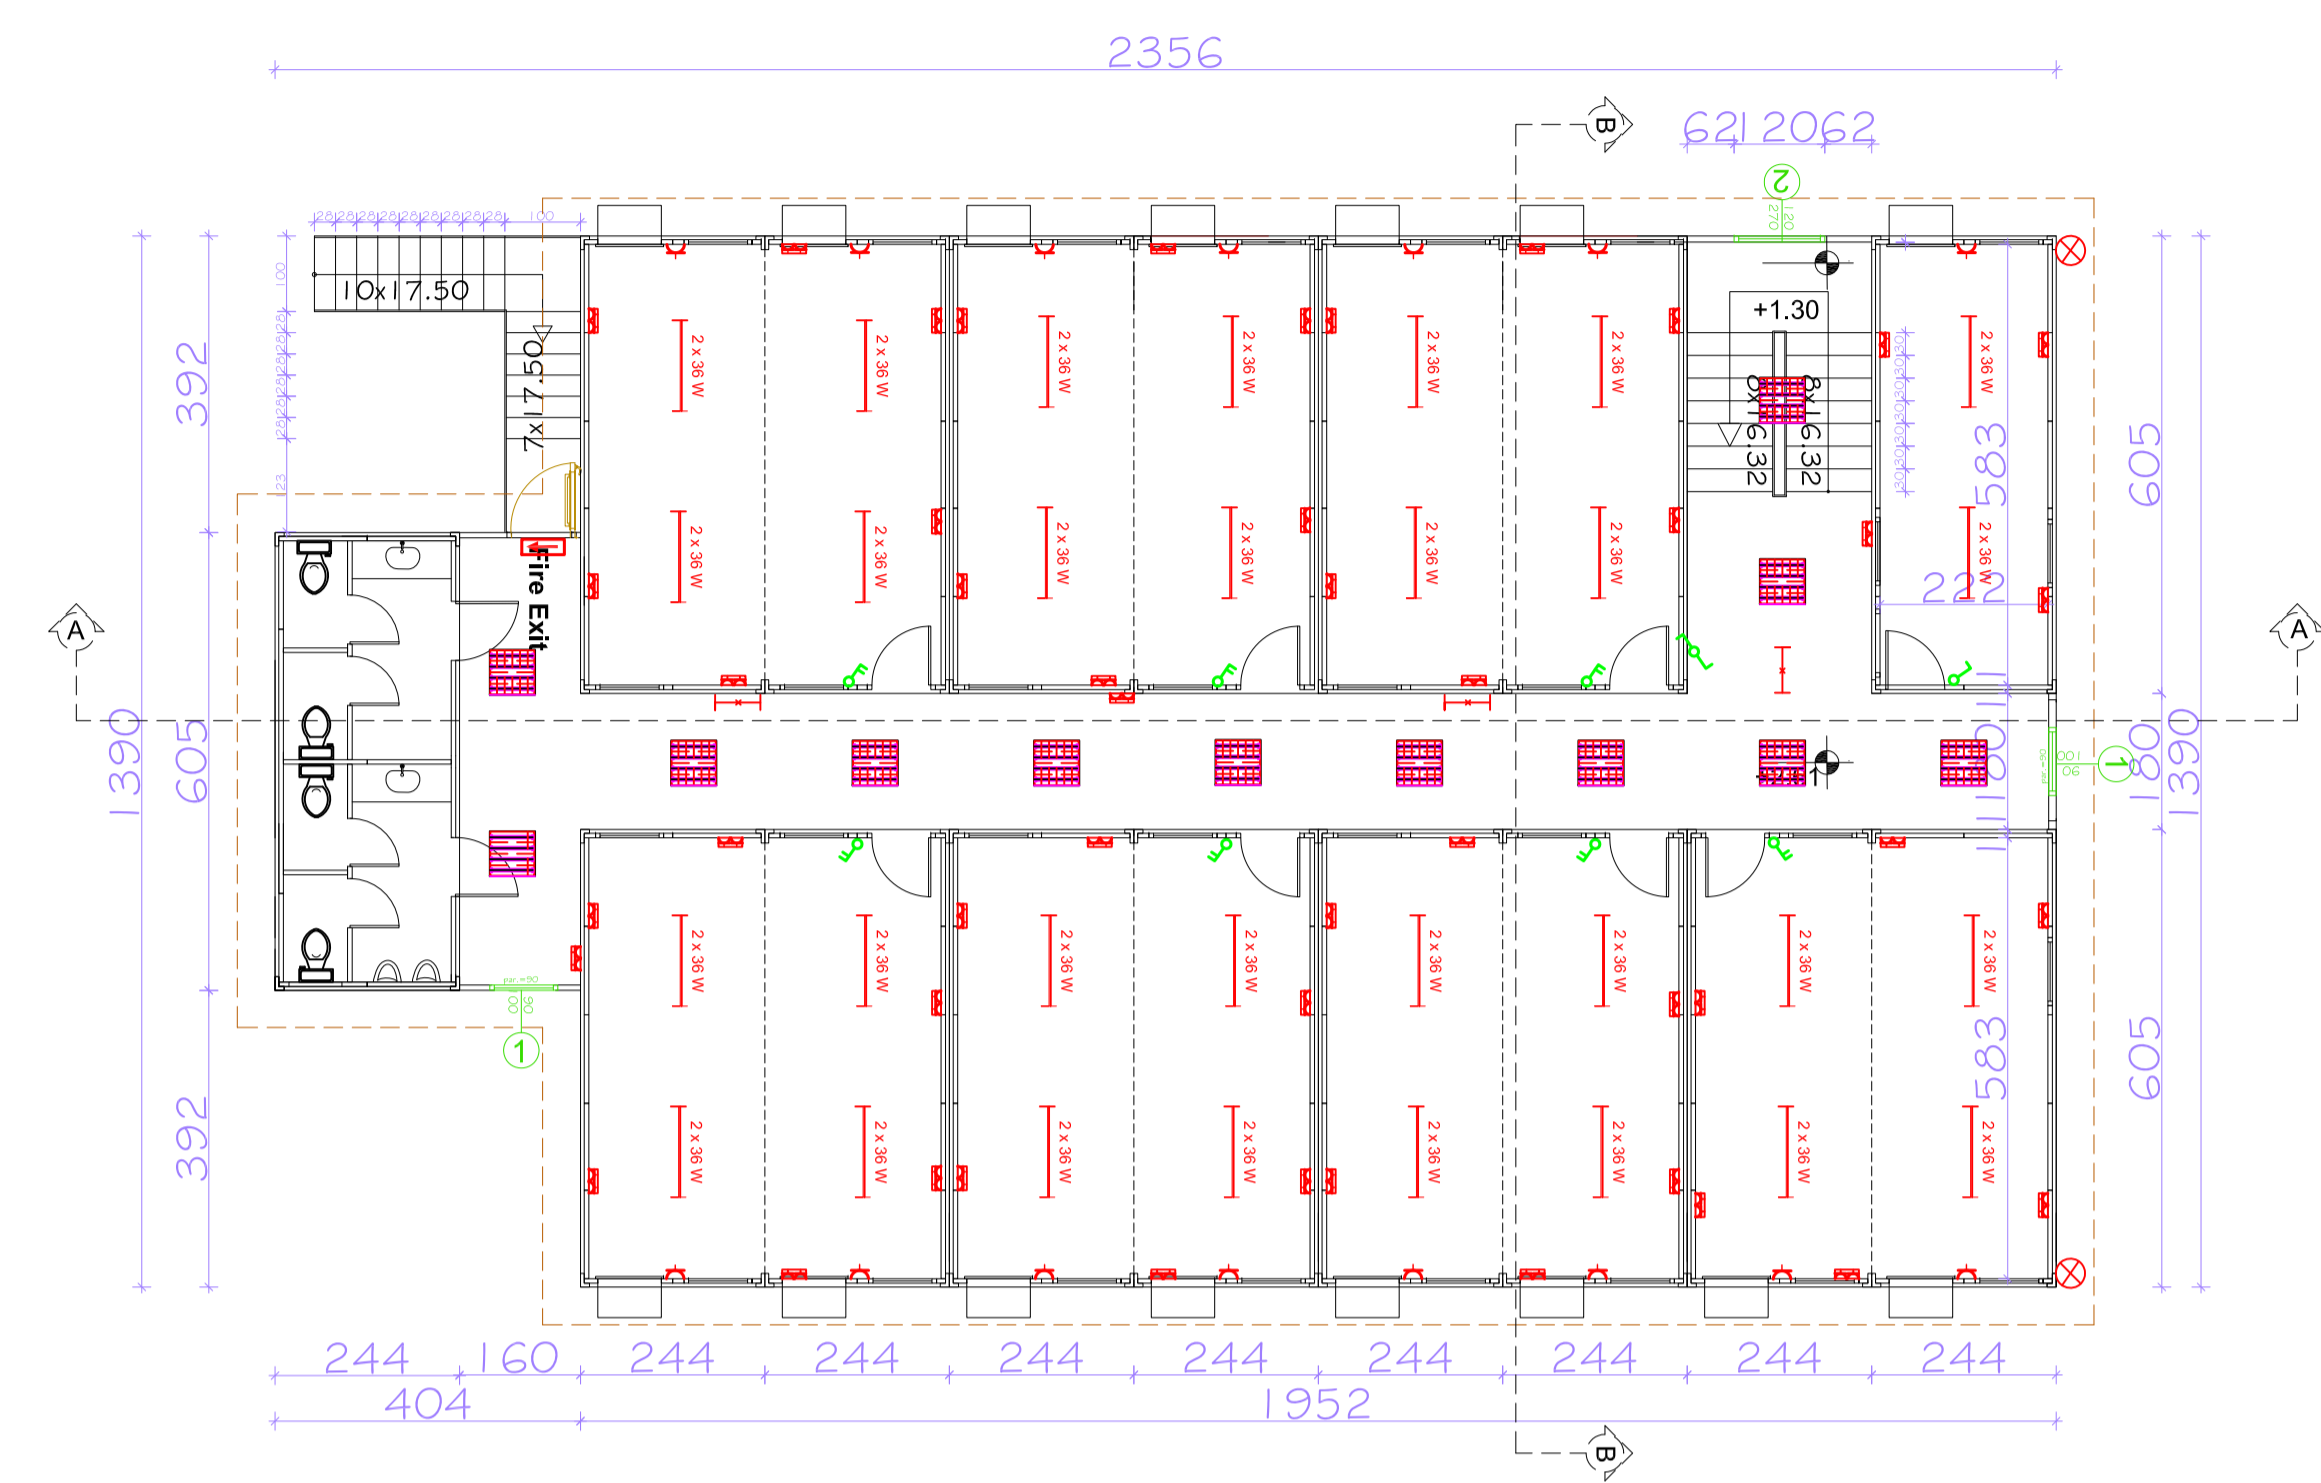
 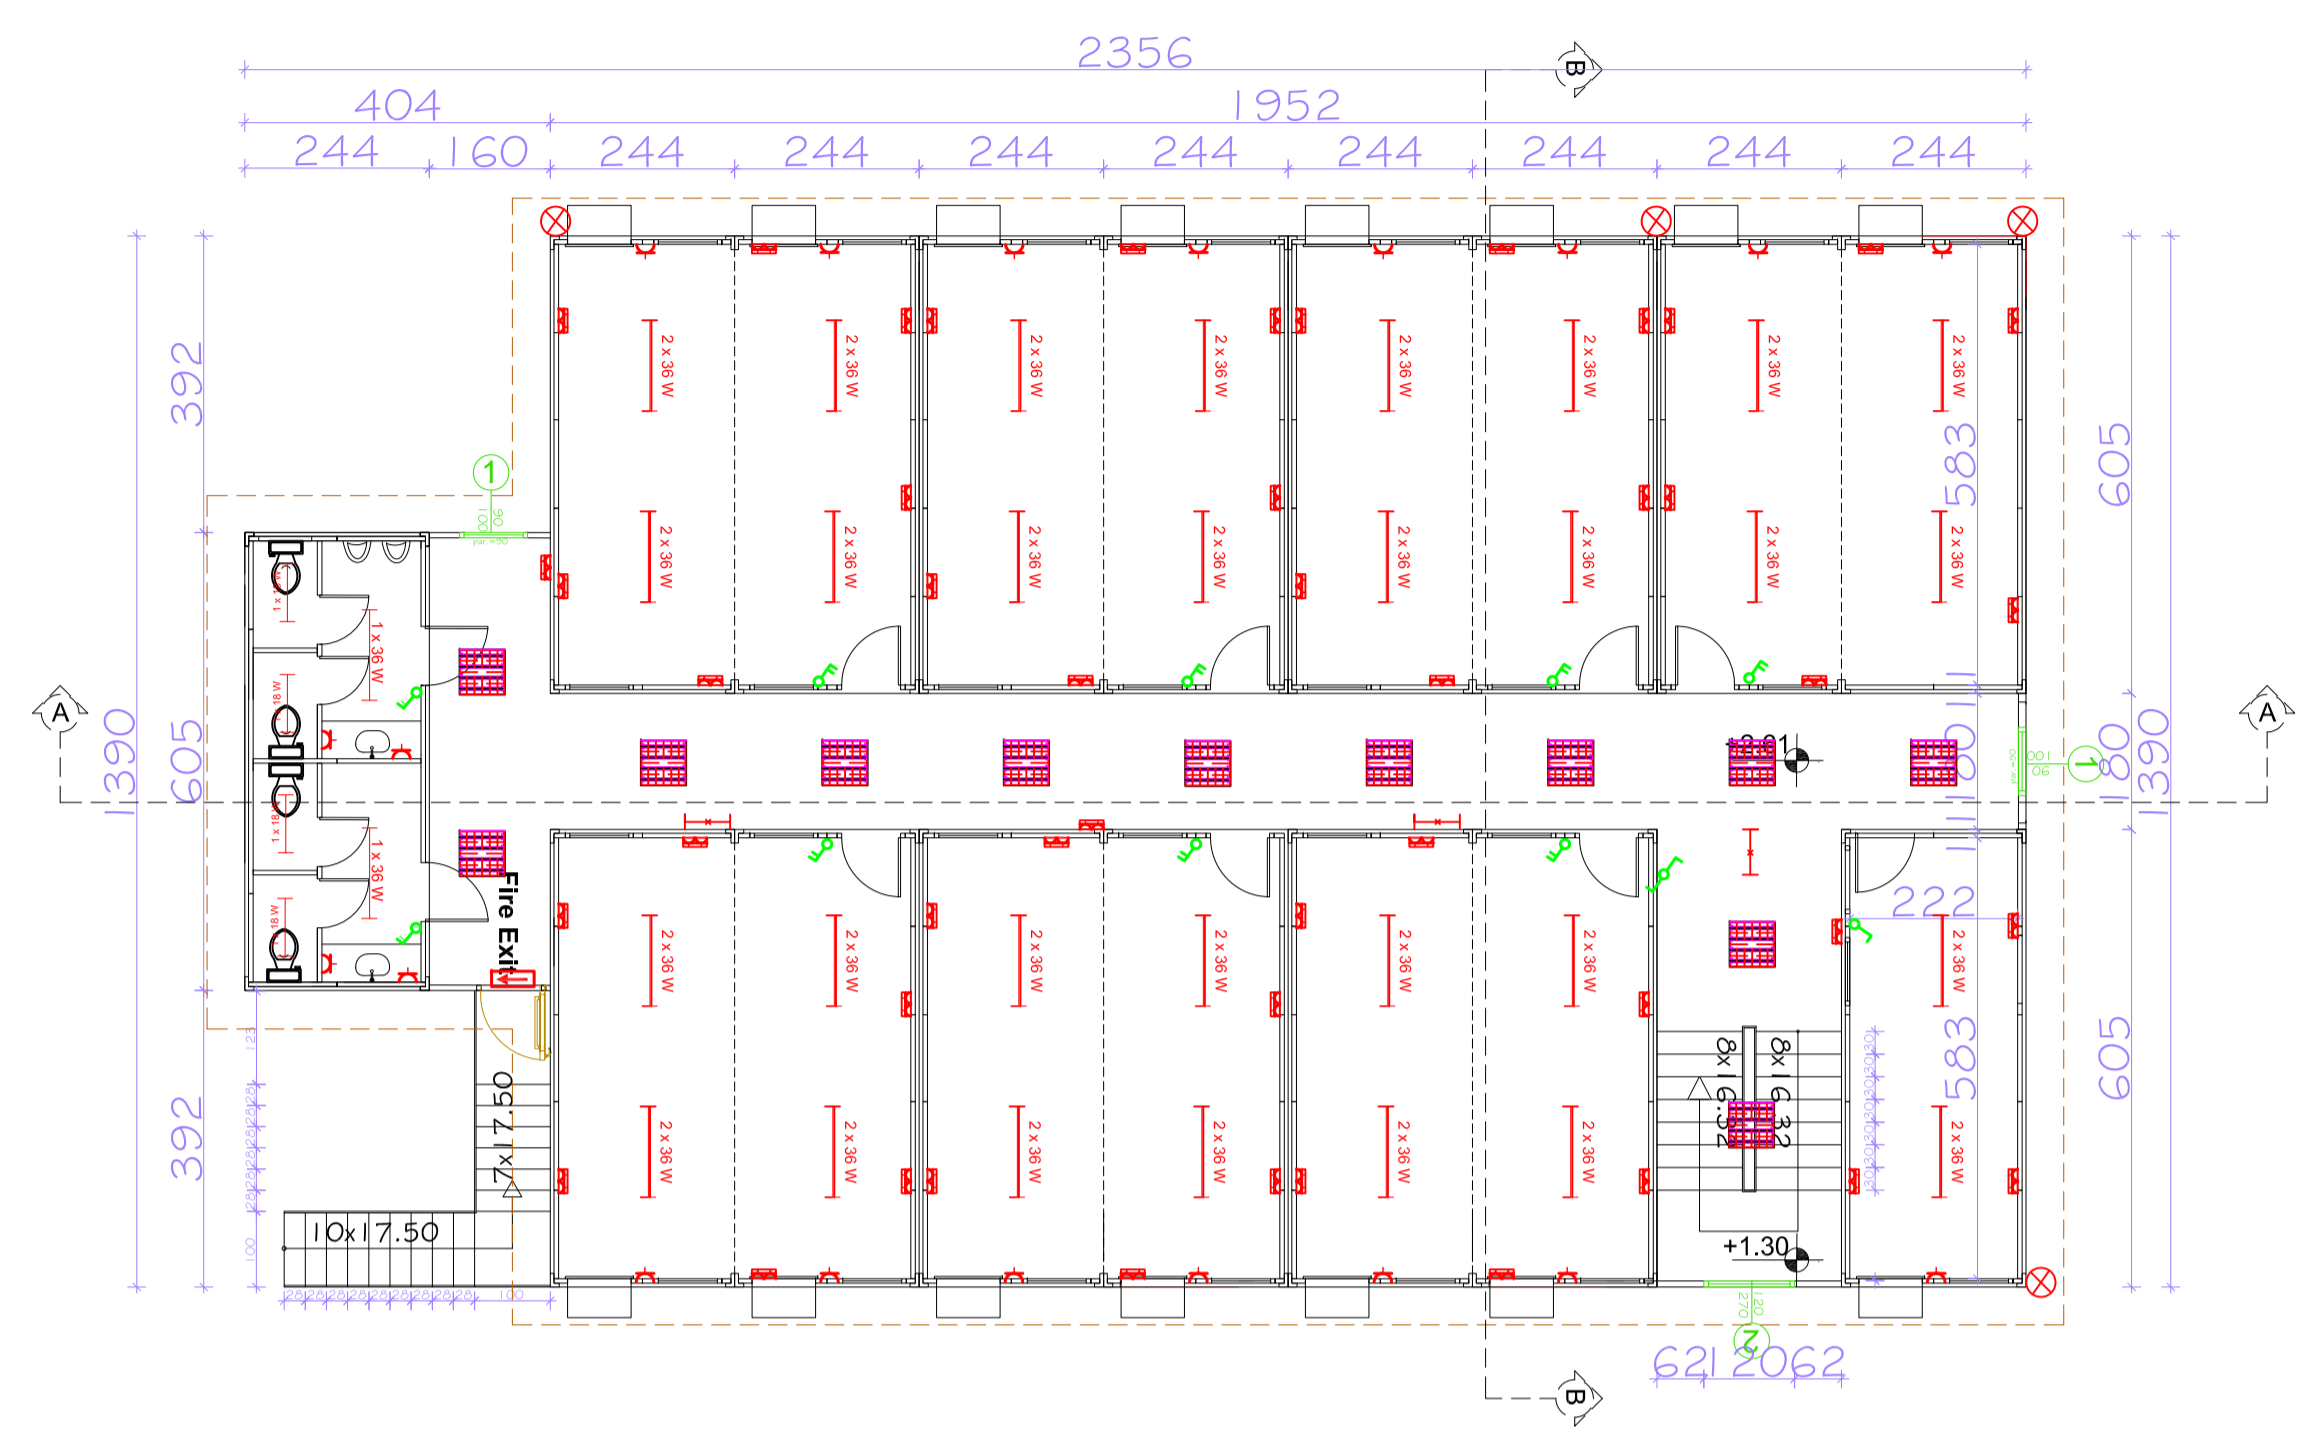

 






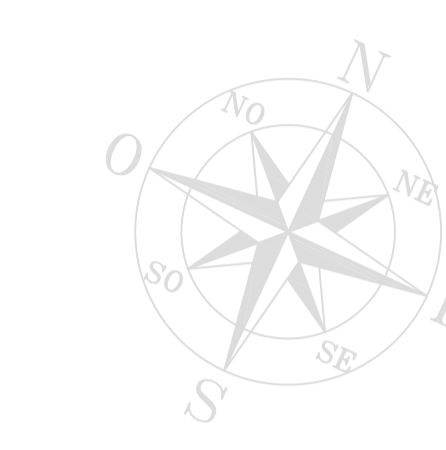


**BUILDING MANAGEMENT UNIT
EULEX-KOSOVO**



LEGEND


-  Distribution Box
-  Fluorescent light unit 4x18W
-  Fluorescent Light Unit 2x36
-  Fluorescent Light Unit 1x36
-  Fluorescent Light Unit 1x18
-  Emergency Light unit
-  Light switches
-  1p/220V- Socket outlet
-  1p/220V- Socket outlet double
-  External Street light 125W
-  3p/380V : Socket outlet
Priza :3p/380V

PROJECT TITLE:
New WH Compound

LOCATION: PRISHTINA


DRAWING TITLE:
RUB HALLS - ELECTRICAL FLOOR PLAN

APPROVED BY:	
CHECKED BY:	
DESIGNED BY:	EULEX-BMU
SCALE:	NA
UNITS	cm
DRAWING NO:	E-03
DATE:	January 2013
	FORMAT A1

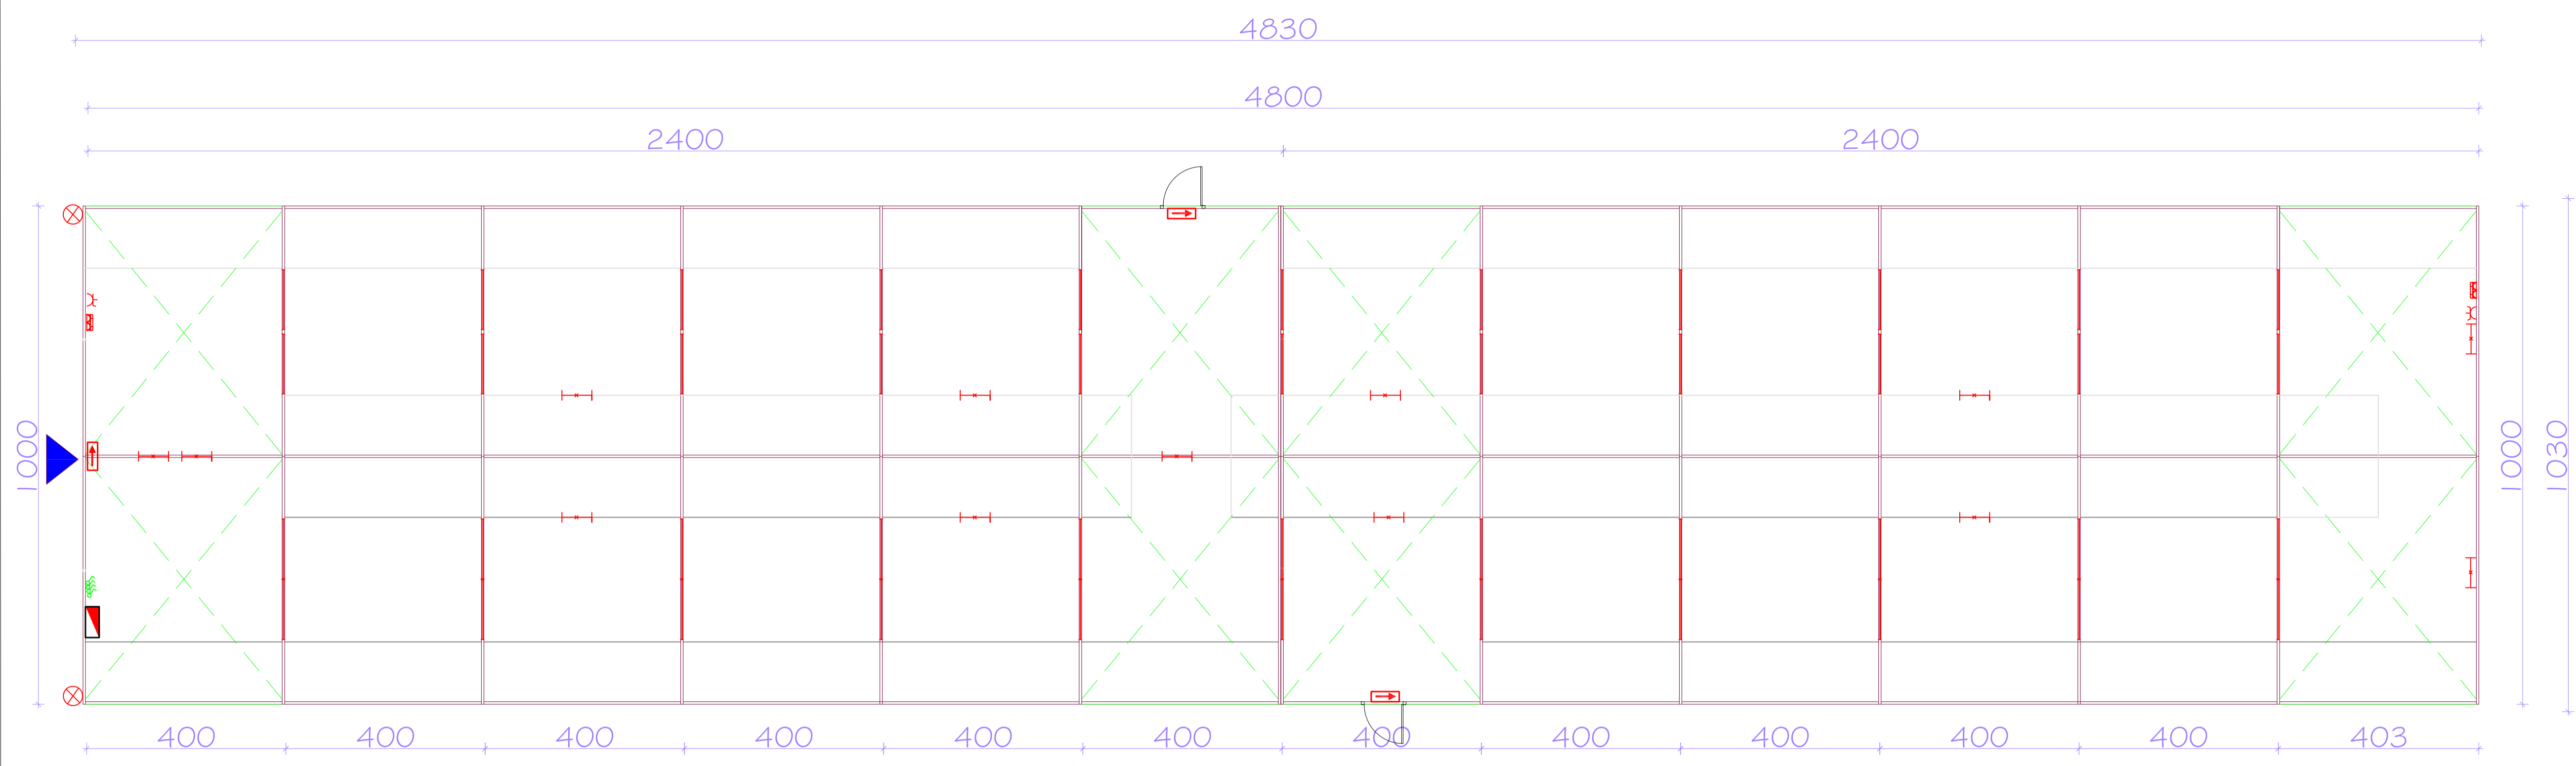

Rub Hall 1


Rub Hall 2

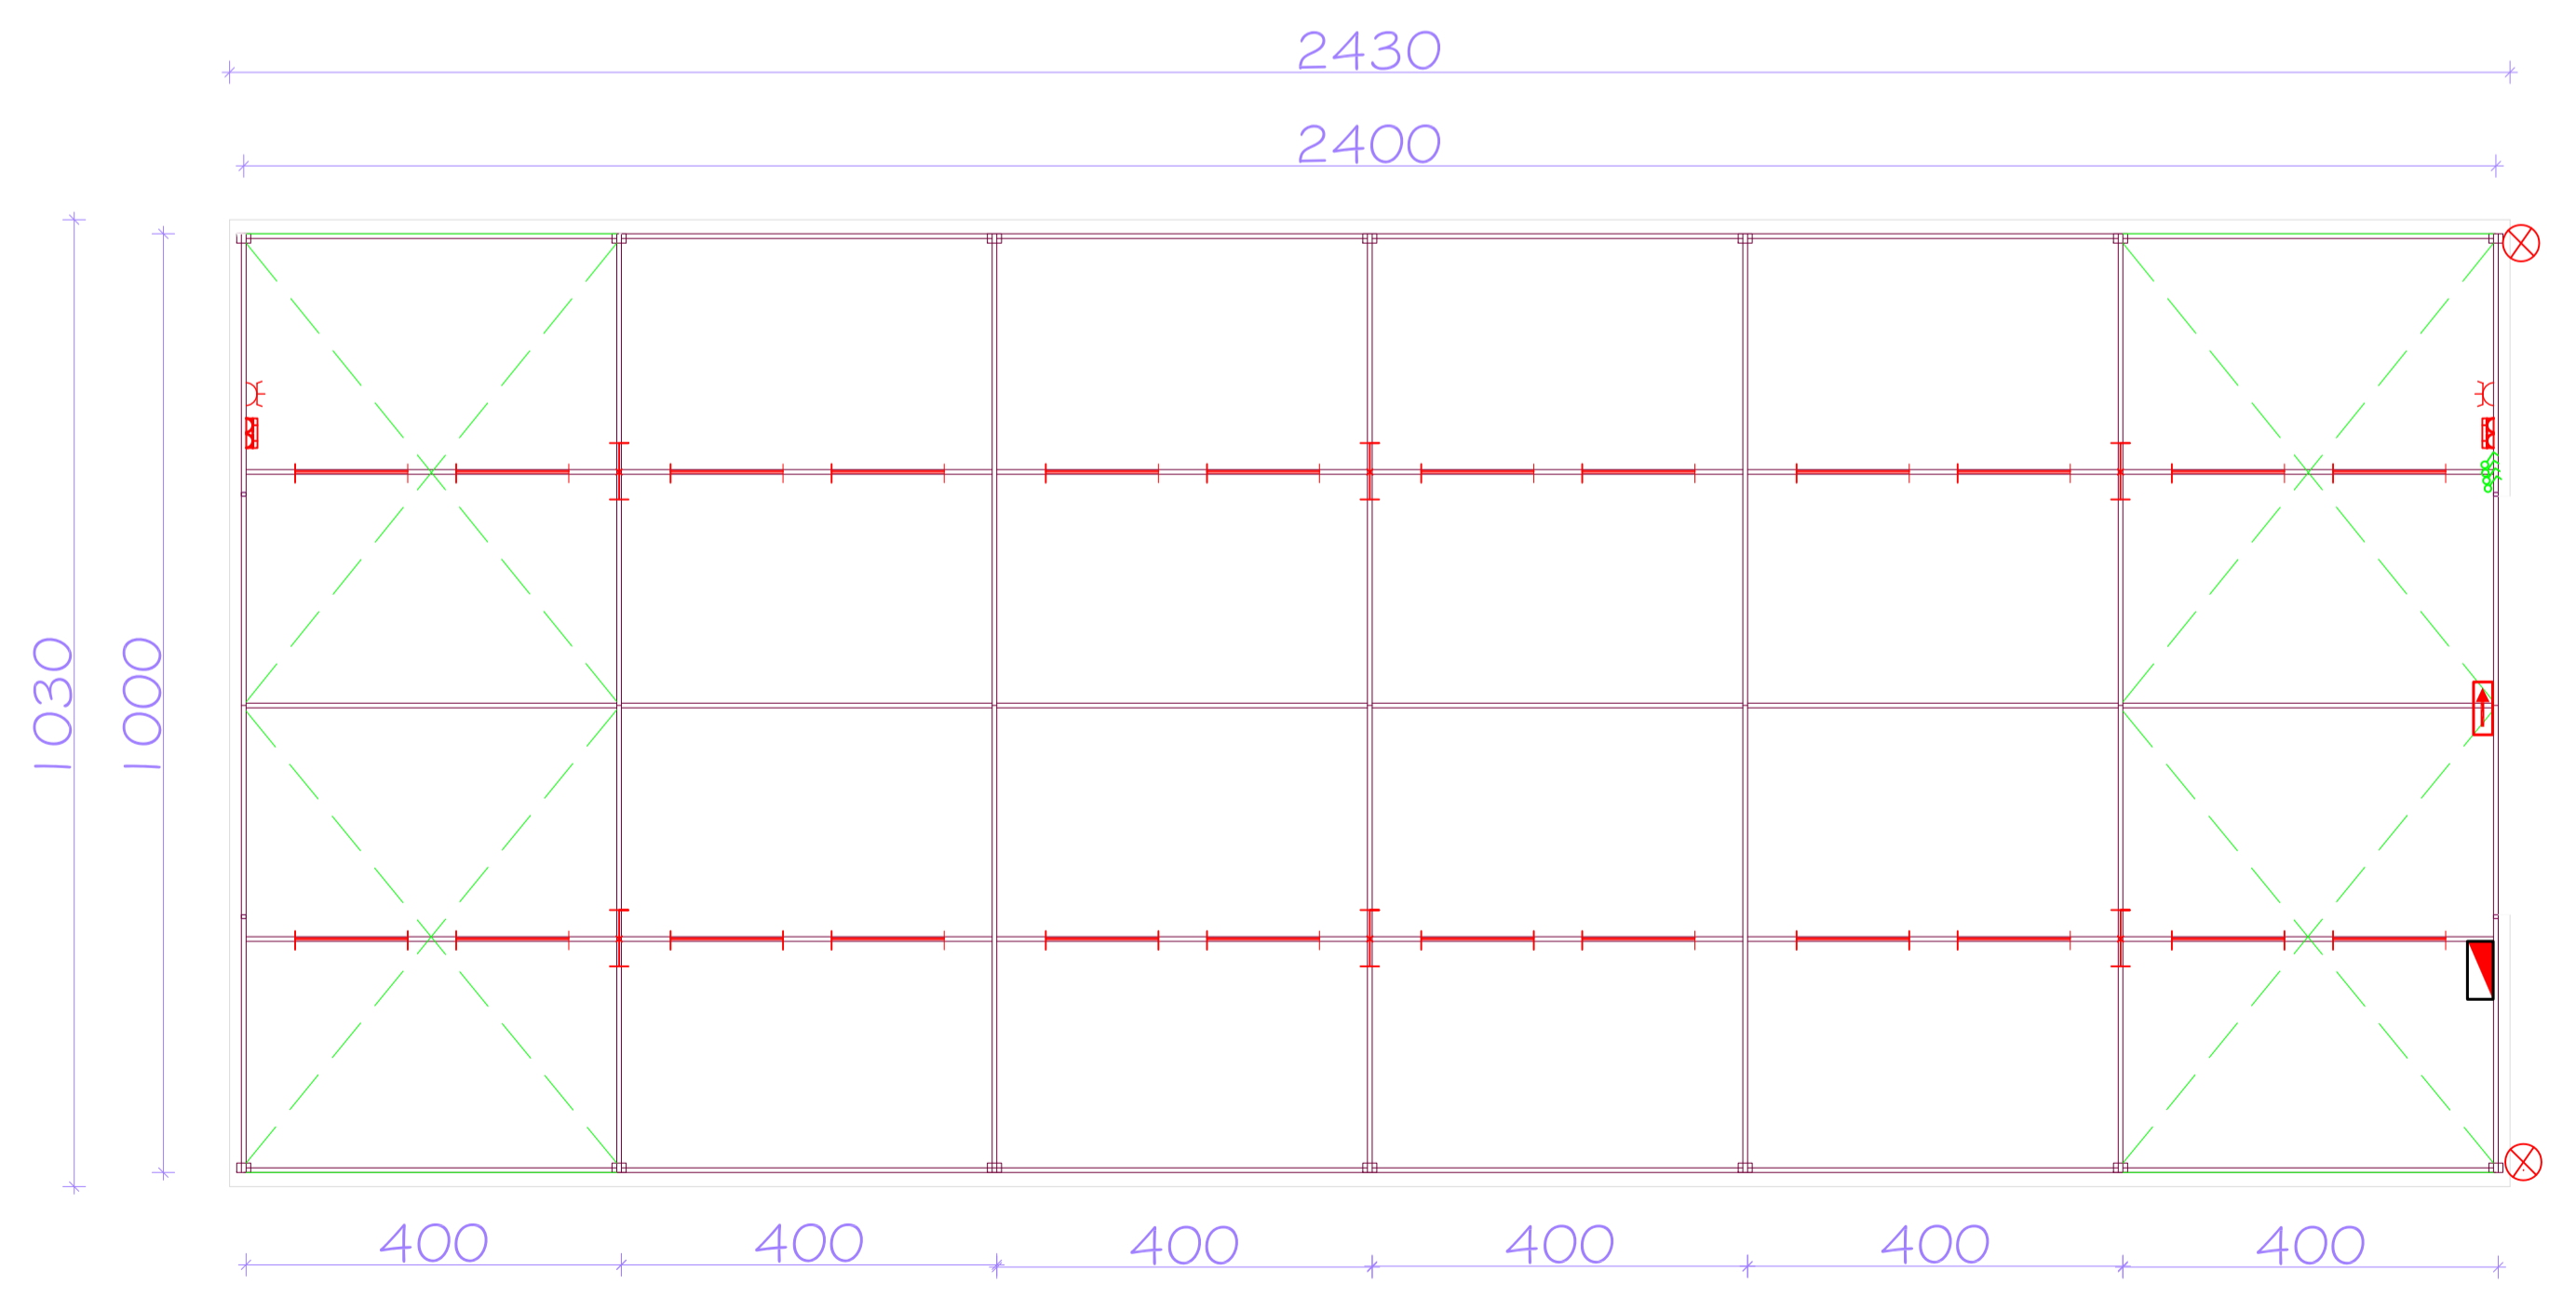

 


 

 


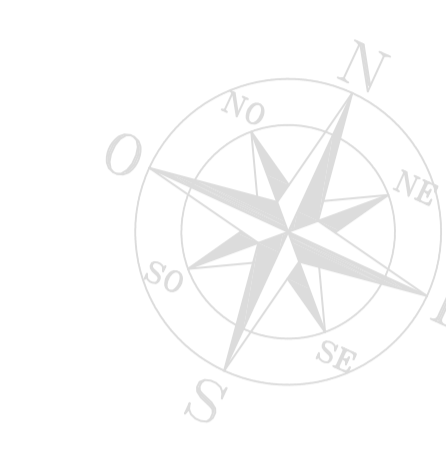


Rub Hall 3




**BUILDING MANAGEMENT UNIT
EULEX-KOSOVO**



LEGEND

-  Distribution Box
-  Fluorescent light unit 4x18W
-  Fluorescent Light Unit 2x36
-  Fluorescent Light Unit 1x36
-  Fluorescent Light Unit 1x18
-  Emergency Light unit
-  Light switches
-  1p/220V- Socket outlet
-  1p/220V- Socket outlet double
-  External Street light 125W
-  3p/380V : Socket outlet
Priza :3p/380V

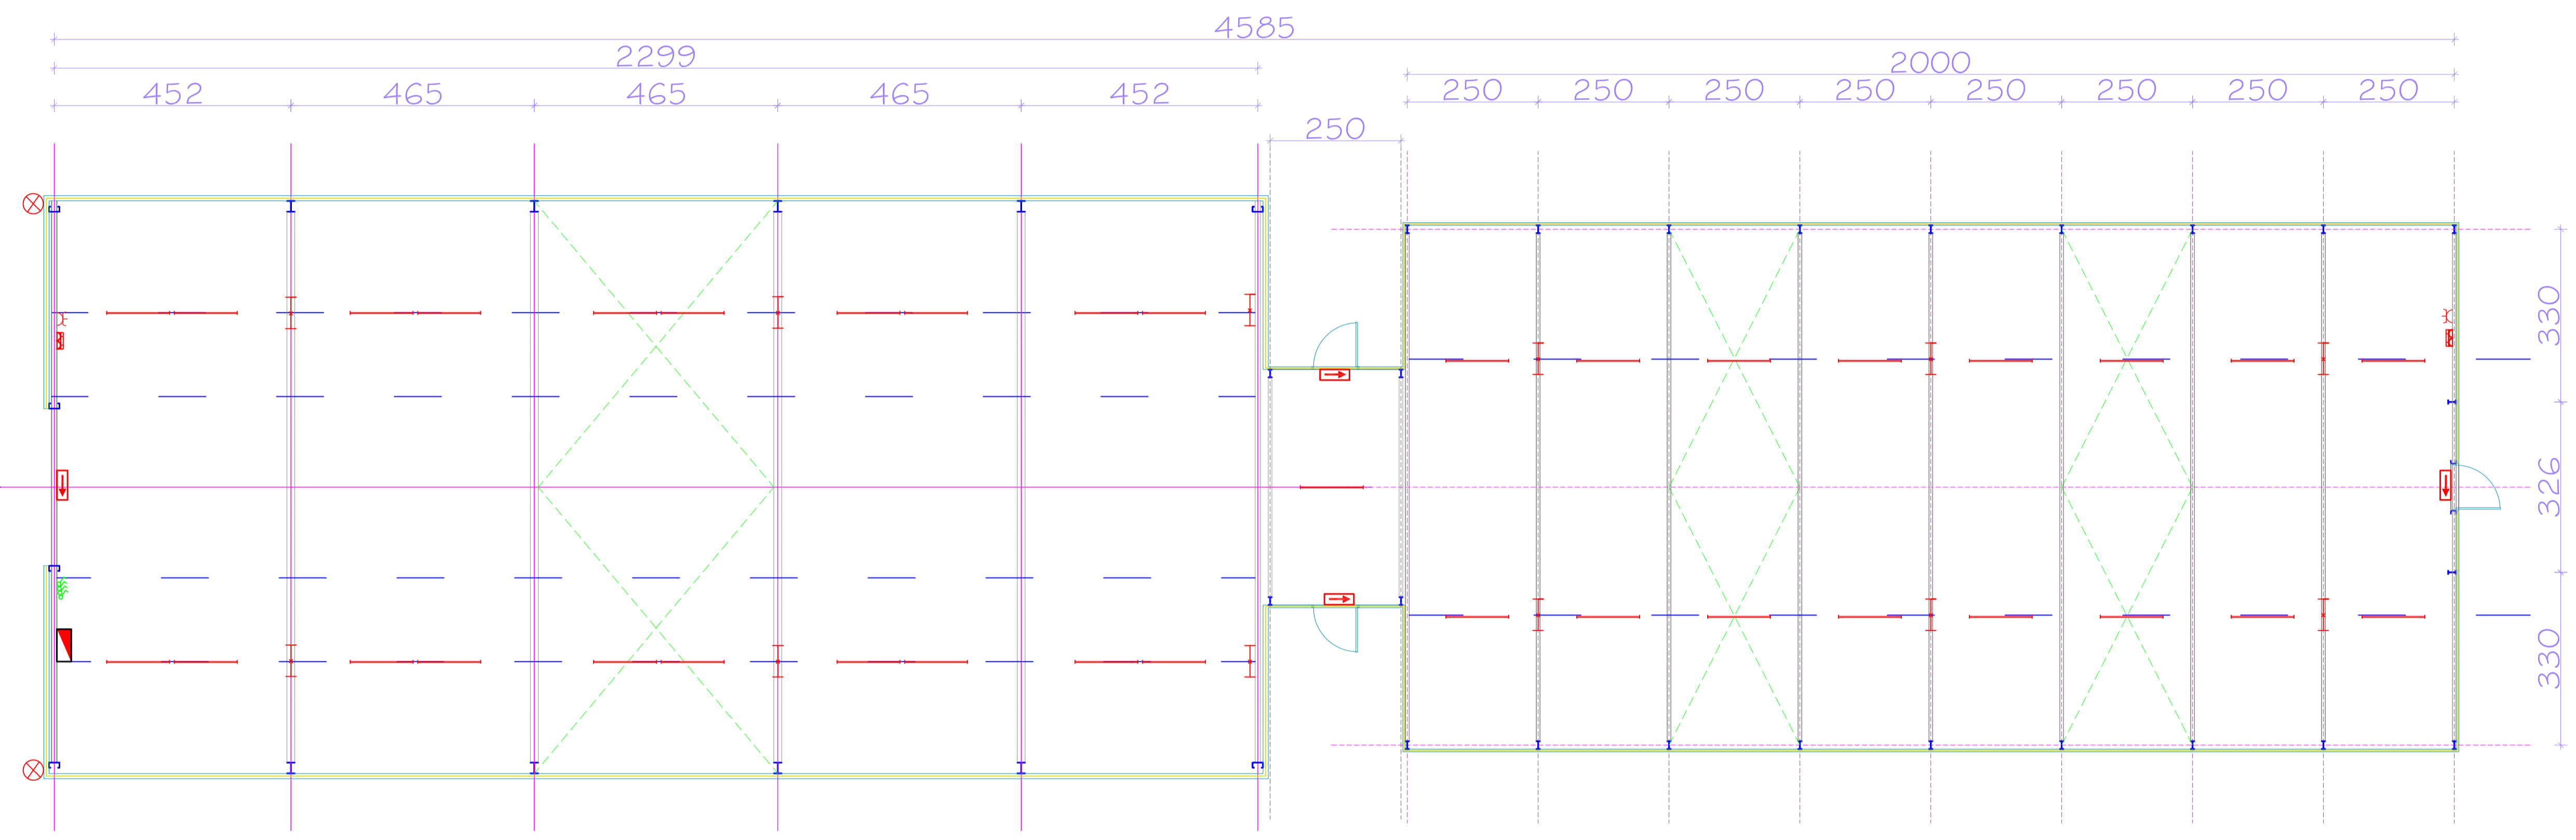

HardWall 1

Hardwall 2

PROJECT TITLE:
New WH Compound

LOCATION: PRISHTINA

DRAWING TITLE:
HARDWALLS
ELECTRICAL FLOOR PLAN

APPROVED BY:	
CHECKED BY:	
DESIGNED BY:	EULEX-BMU
SCALE:	N/A
UNITS:	cm
DRAWING NO:	E-04
DATE:	January 2013
	FORMAT A1